

**CORRIGENDUM-2****CLARIFICATIONS TO BIDDER'S QUERIES**

Name of work: - Providing Electrical works at transit campus building of IISER Tirupati, Andhra Pradesh.
 NIT NO : 2/IISER/TIRUPATI/2017-18

Bidders are requested to refer clarifications of Questions/ queries/ clarifications submitted by bidder through email/fax are listed below.
 Bidders shall go through clarifications and quote accordingly.

Sr No	Bidder's Query	Clarifications by IISER
1	PLEASE PROVIDE DRAWINGS IN AUTOCAD & ALSO SLD FOR LT PANELS.	Drawings required for reference of bidders are already provided along with tender document . Additional drawings in pdf format are provided for reference purpose of bidder. SLD for LT panel provided along with this corrigendum-2 for reference purpose.
2	IN POINT WIRING, WHETHER WE CONSIDER FR OR FRLS CABLE OR WIRES?	Bidder shall consider " FRLS cables/wires " for all point/Circuit wiring specified in Bill of Quantity and technical specifications. No change in quantity and unit of items.
3	SR NO. 16. 25MM PVC CASING UNIT IS EACH IN EXCEL & MTR IN PDF.	Sr.No 16 , Bill of Quantity , Unit of measurements stands modified to " meter " . Bidder shall take note it and quote accordingly. No change in quantity of item.
4	SR NO. 22.01,22.02 & 22.03 PLEASE SUGGEST CURRENT RATING FOR SWITCH & SOCKET.	Sr. No 22.01 , Sr. No 22.02 and Sr. No. 22.03 of bill of quantity current rating shall be 6A/16A Universal type socket and 16A switch. Bidder shall quote accordingly. No change in quantity and unit of item.
5	SR. NO. 27.16 FOR ANGER BOARD THERE ARE DIFFERENT QTY IN EXCEL & PDF.	Bidder shall refer Bill of Quantity in excel sheet format and quote rates in excel sheet and upload on portal accordingly. Any deviations between pdf and excel sheet of BOQ , contents of excel sheet shall be referred as final.
6	SR. NO. 43 FOR CAT-6 CABLE THERE ARE DIFFERENT QTY IN EXCEL & PDF.	
7	PDF and Excel BOQ copy	
8	Bill of Quantity , Sr.No- 42.03	Bidder shall read cable size specified in Sr.No 42.03 as " 3.5 X 300 Sqmm " . No change in quantity and unit of item.

The original tender document and conditions already issued to agency stands modified to the extent of modifications defined in above CORRIGENDUM-2 CLARIFICATIONS TO BIDDERS QUERIES and shall form part of tender document. The bidders are requested to submit duly signed the corrigendum and all its enclosures along with the tender document on due date of submission of tender. The bidders are further requested to take note of above modifications & quote rates accordingly. Soft copies of Corrigendum are already uploaded on <https://eprocure.gov.in/eprocure/app> and www.iisertirupati.ac.in

Enclosures :



- 1 PDF copy of SLD for HVAC PDB
- 2 PDF copy of SLD for Building DB
- 3 PDF copy of FA & CCTV Layout
- 4 PDF copy of Power Layout.



Engineer In-charge



SYMBOL	DESCRIPTION
⊖	SMOKE DETECTOR BELOW FALSE CEILING
⊗	SMOKE DETECTOR ABOVE FALSE CEILING WITH RESPONSE INDICATOR
⊕	MANUAL CALL POINT (MCP)
⊘	STROBER CUM HOOTER
⊙	REPEATER PANEL
⊚	IP-BASE DOME TYPE CCTV
⊛	IP-BASE IR BULLET TYPE CCTV

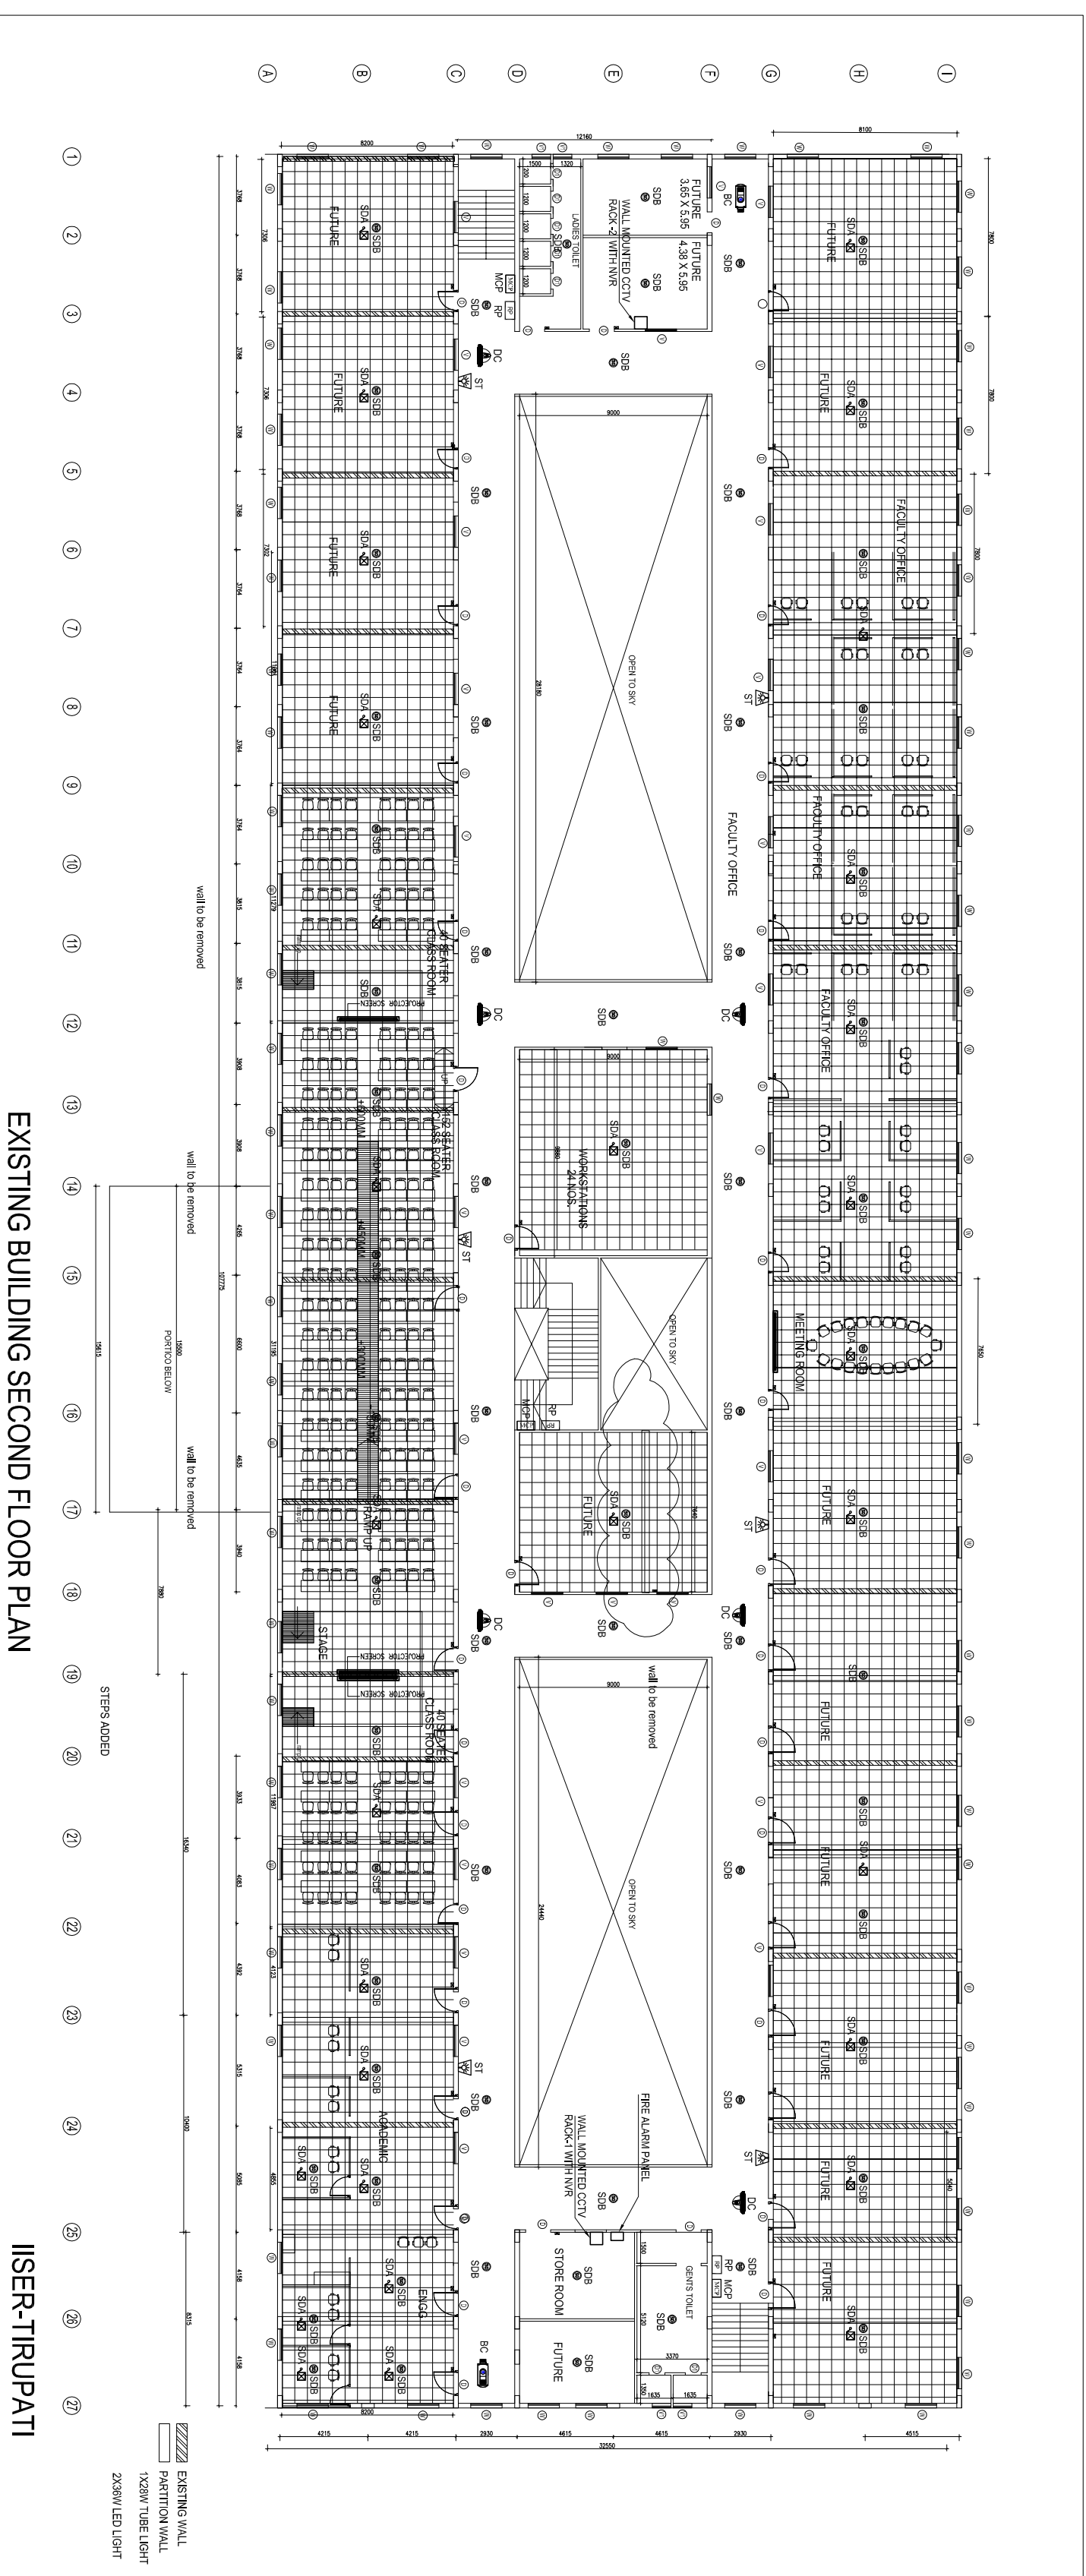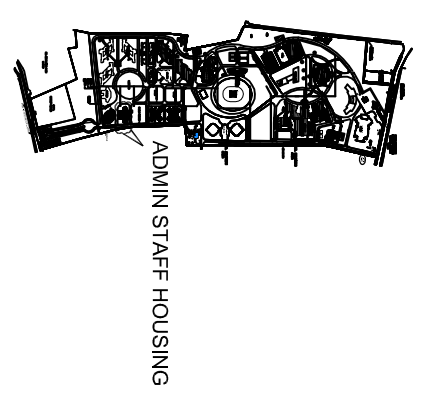

EXISTING BUILDING SECOND FLOOR PLAN

IISER-TIRUPATI

FOR TENDER ONLY

REV	ISSUED FOR TENDER	DESCRIPTION	DATE	BY
R0			21.04.17	PKM
				YPS

CLIENT: INDIAN INSTITUTE OF SCIENCE EDUCATION AND RESEARCH(IISER), TIRUPATI.

PROJECT: PROPOSED CAMPUS FOR IISER,PUNE

ELECTRICAL CONSULTANT: EMEA
 Design and Consultant
 Ground floor 5, No. 46/07/1/1,
 2nd floor 5, No. 47/03,
 Madhavachari Road,
 Bangalore - 560075
 Mobile: 98451 41003
 Email: emea@emea.co.in

DRAWING TITLE: FA & CCTV LAYOUT FOR EXISTING ADMIN BUILDING

SCALE: 1: 200

DATE: 21.04.17

CLIENT SIGNATURE: _____

DRAWING NO: IISER / CRN / EMEA / ELV/01

ARCHITECTURE & INTERIOR DESIGN & ENGINEERING & PLANNING & CONSTRUCTION MANAGEMENT

CRN

C. K. MANAVANA RAO

10, KARUNAGIRI NAGAR,
 MYLAPORU, CHENNAI-600 004

B. Inoh, (Ism), M.S., (IIL), Ph.D., Usm,Sec. C.E., F.I.E., F.I.V.,
 Chartered Engineer - Registered Architect.

EXISTING TRANSIT BUILDING

Construction work shall be executed only as per the latest revision drawing. Once a revision drawing is issued, the validity of the previous revision drawing stands cancelled and as such construction shall not be carried out as per superseded revisions. The Contractor is expected to maintain a register of Drawing Receipts, listing drawing number, title, from whom received, date received, number of copies received, details of transmittal from the issuer & any other relevant details to be advised from time to time.

2. Archive of previous revision issues immediately upon receipt of a new revision and no superseded drawing shall remain in the site of works except in the Contractor's archives for record and reference purposes only.

3. While archiving superseded drawings, the Contractor is expected to stamp all previously issued drawings / prints appropriately, mentioning the date and revision number of the new revision in account of which the previous revision is archived.

4. The Contractor shall allow the representative of Client / PMC / Architect to inspect Contractor's archives for ensuring compliance.

5. Any work carried out by the Contractor using a superseded drawing after the issue of a new revision is liable for rejection and reinstatement as per new revision at Contractor's risk and cost without any entitlement to extension of time.

